



N:\Clients\698 City of Santa Cruz\14-16-01 GHWP Tank Imprvmts\CAD\Production\698-14-16-01-C012-C014.dwg 3/16/2020 1:20 PM tnewman

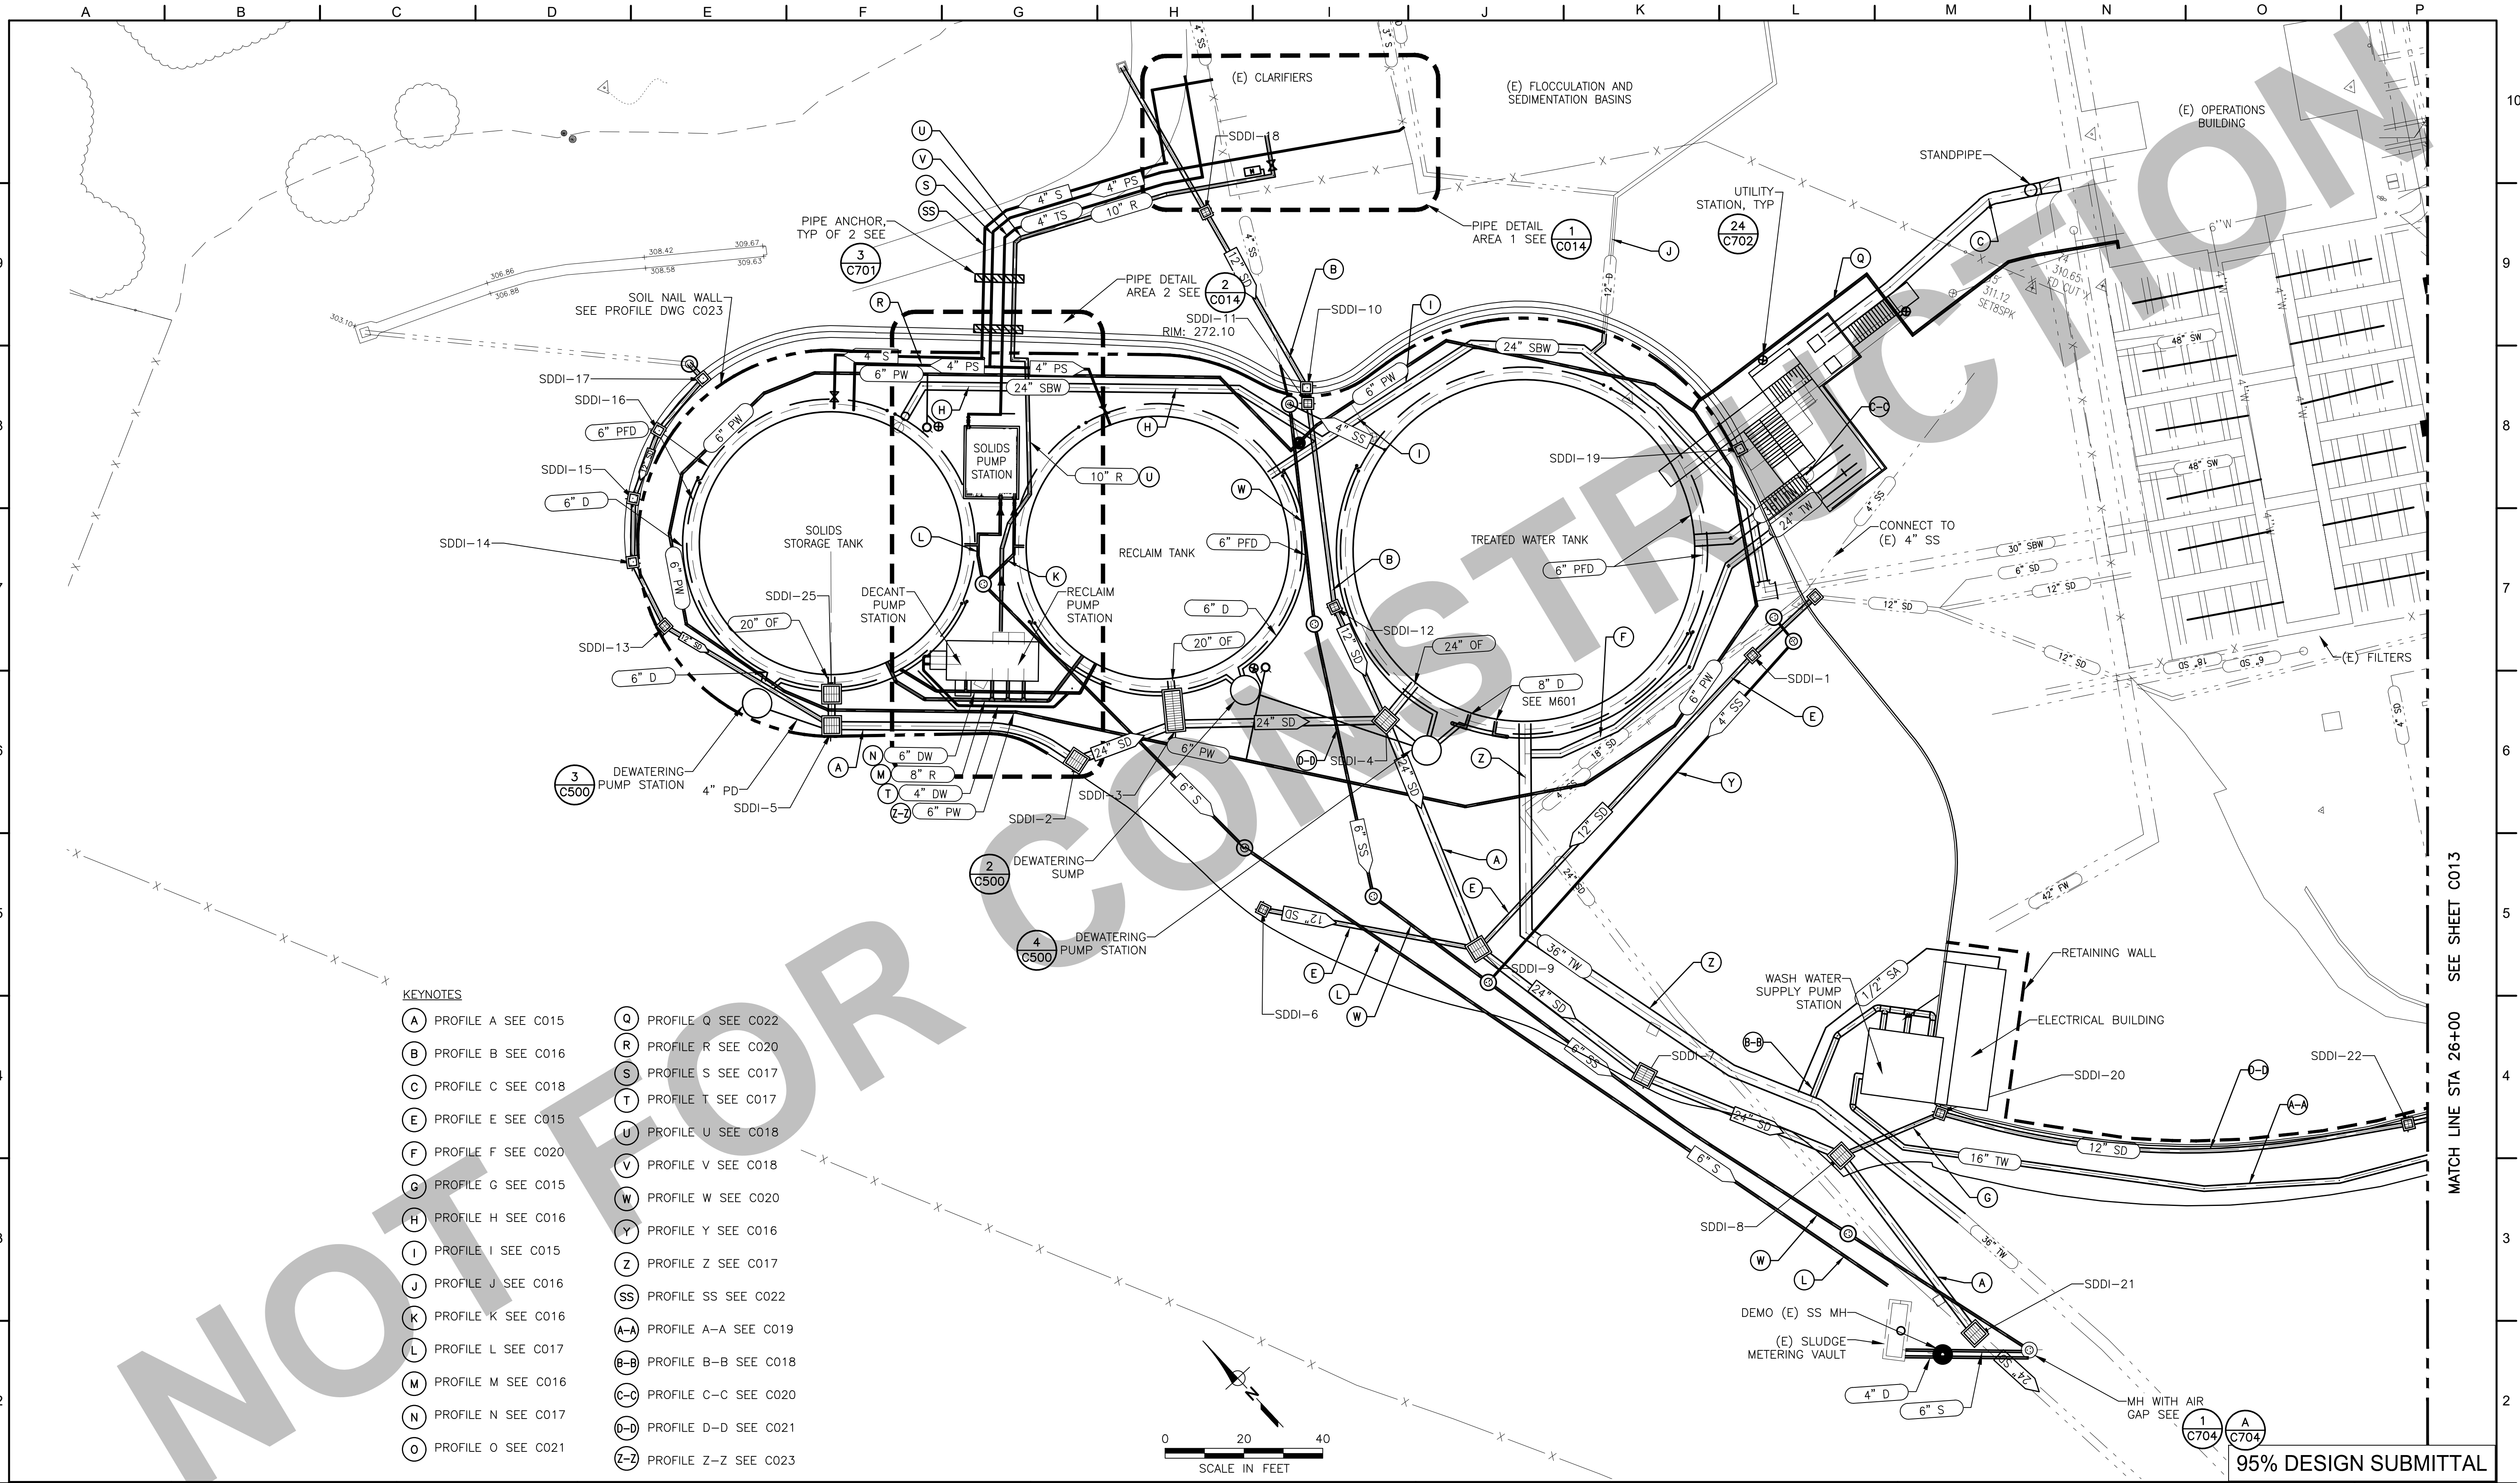

- KEYNOTES**
- (A) PROFILE A SEE C015
 - (B) PROFILE B SEE C016
 - (C) PROFILE C SEE C018
 - (E) PROFILE E SEE C015
 - (F) PROFILE F SEE C020
 - (G) PROFILE G SEE C015
 - (H) PROFILE H SEE C016
 - (I) PROFILE I SEE C015
 - (J) PROFILE J SEE C016
 - (K) PROFILE K SEE C016
 - (L) PROFILE L SEE C017
 - (M) PROFILE M SEE C016
 - (N) PROFILE N SEE C017
 - (O) PROFILE O SEE C021
 - (Q) PROFILE Q SEE C022
 - (R) PROFILE R SEE C020
 - (S) PROFILE S SEE C017
 - (T) PROFILE T SEE C017
 - (U) PROFILE U SEE C018
 - (V) PROFILE V SEE C018
 - (W) PROFILE W SEE C020
 - (Y) PROFILE Y SEE C016
 - (Z) PROFILE Z SEE C017
 - (SS) PROFILE SS SEE C022
 - (A-A) PROFILE A-A SEE C019
 - (B-B) PROFILE B-B SEE C018
 - (C-C) PROFILE C-C SEE C020
 - (D-D) PROFILE D-D SEE C021
 - (Z-Z) PROFILE Z-Z SEE C023

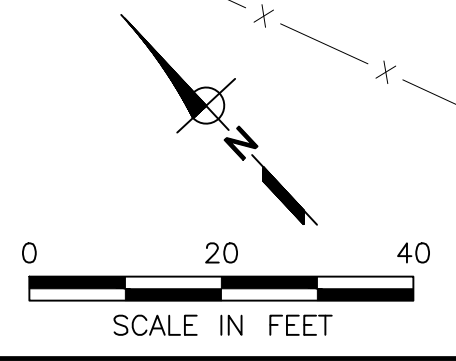

MATCH LINE STA 26+00 SEE SHEET C013

95% DESIGN SUBMITTAL

NOT FOR CONSTRUCTION

THIS LINE IS 1 INCH
AT FULL SCALE
IF NOT SCALE ACCORDINGLY

SCALE : 1"=20'

DRAWN BY : XXX

DESIGNED BY : _____

PROJ. MGR. : JW

No.	ZONE	REVISIONS	BY	DATE



2020 Research Park Drive
Suite 100
Davis, California 95618
(530) 756-5905
FAX (530) 756-5991



GHWTP CONCRETE TANKS REPLACEMENT PROJECT

GHWTP SITE YARD PIPING PLAN 1

JOB NUMBER 698-14-16-01
DRAWING NUMBER C012
SHEET NUMBER XX OF XX
REVISION